




No electrical to be installed

- 1st SW Paint Color: 7563 Restful White
- 2nd SW Paint Color: 9520 Nocturne
- Text SW Paint Color: 6258 Tricorn Black

SW Paint=Brick colors :

- 6060 Moroccan Spice
- 0034 Roycroft Rose
- 6332 Coral Island
- 7563 Restful White (mortar)

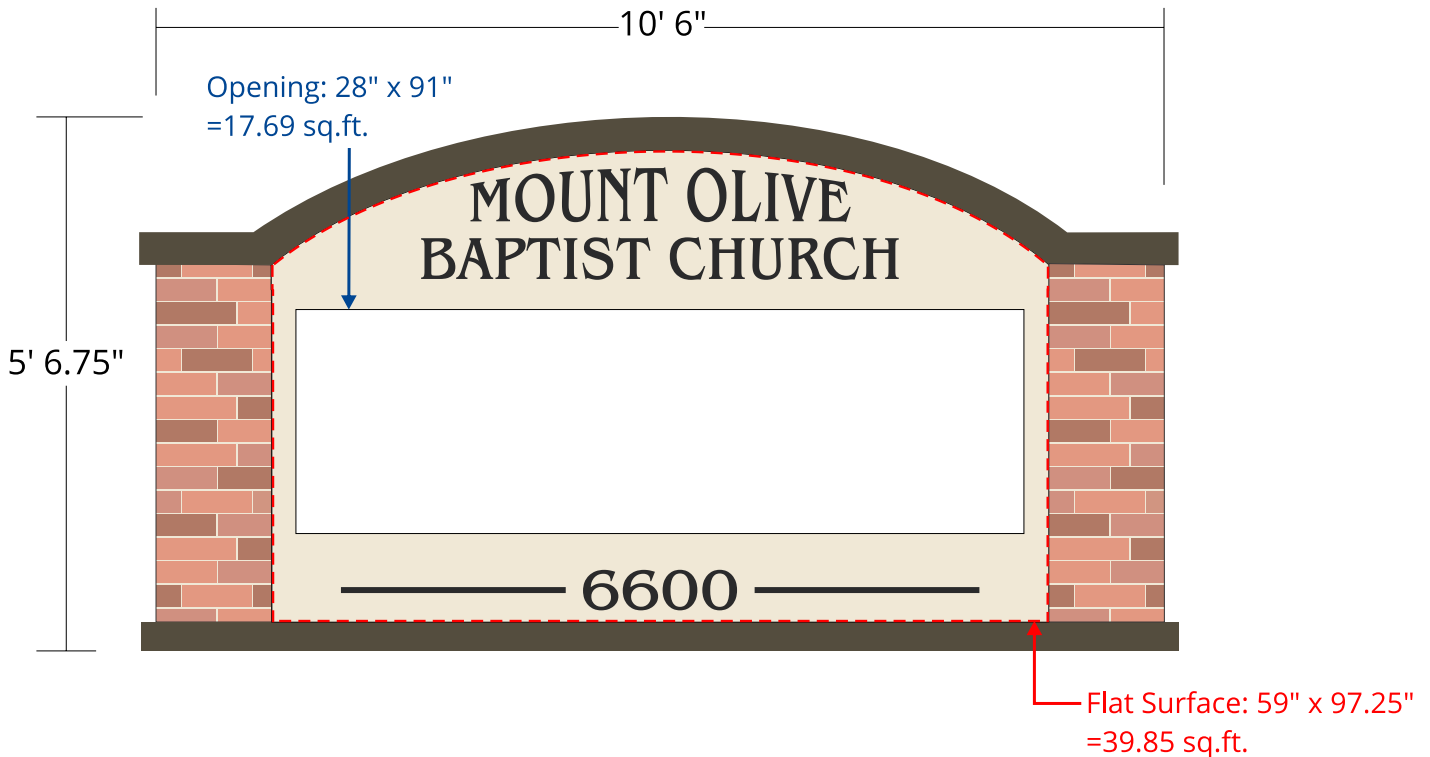

1st Sold Revision

Stewart Signs
ONE SIGN, ONE COMPANY
1-800-237-3928 stewartsigns.com

Cornerstone Model 51
Double Sided

Sk: 1026948-2b-s Cust: 1382377
2/19/2024 CgO/tBoos SOLD
Scale: 1/2"=1'

Signature _____

Date _____


Please confirm that all lettering, colors and graphics are correct before signing. Changes to artwork after signature is received will incur a \$500 art change fee.




LUMINAIRE SCHEDULE -- FIXTURES ARE BY RUUD OR EQUAL								
Symbol	Label	Catalog Number	Description	Lamp	File	Lumens	LLF	Watts
	A	MPR615	12" PARKING/ROADWAY AREA LIGHT	ONE 100-WATT CLEAR METAL HALIDE	MPR615.ies	8100	0.75	190
	B	MPR615	12" PARKING/ROADWAY AREA LIGHT	ONE 100-WATT CLEAR METAL HALIDE	MPR_150MH.ies	8100	0.75	380
	C	MPR615	12" PARKING/ROADWAY AREA LIGHT	ONE 100-WATT CLEAR METAL HALIDE	MPR_150MH.ies	8100	0.75	760
	D	MPR615SBL	12" PARKING/ROADWAY AREA LIGHT WITH BACKLIGHT SHIELD.	ONE 100-WATT CLEAR METAL HALIDE	MPR615SBL.ies	8100	0.75	190
	F	MAC615SBL	12" AREA CUTOFF / W/BACK LT. SHIELD	100 WATT MH	MAC_BLS_150 MH.ies	8100	0.75	185

DRAWING NOTES

- CIRCUITRY SHALL GENERALLY BE AS SHOWN ON PLAN. CONTRACTOR MAY REWORK TO FIND BEST FIELD ROUTING. WIRING FOR CIRCUITS UP TO 100'-0" IN LENGTH SHALL BE #10 AWG. WIRING FOR CIRCUITS UP TO 300'-0" IN LENGTH TO BE #8 AWG AND CIRCUITS OVER 300'-0" SHALL BE #6 AWG.
- MINIMUM SIZE CONDUIT SHALL BE 1", PULL GROUND IN ALL CONDUITS.
- DIRECT BURY CABLE WILL BE ALLOWED AS SUBSTITUTE TO CONDUIT/WIRE SPECIFIED PROVIDE SLEEVES BELOW PAVING, WALKS AND ENTRANCE/EXIT FROM CONCRETE POLE BASES.

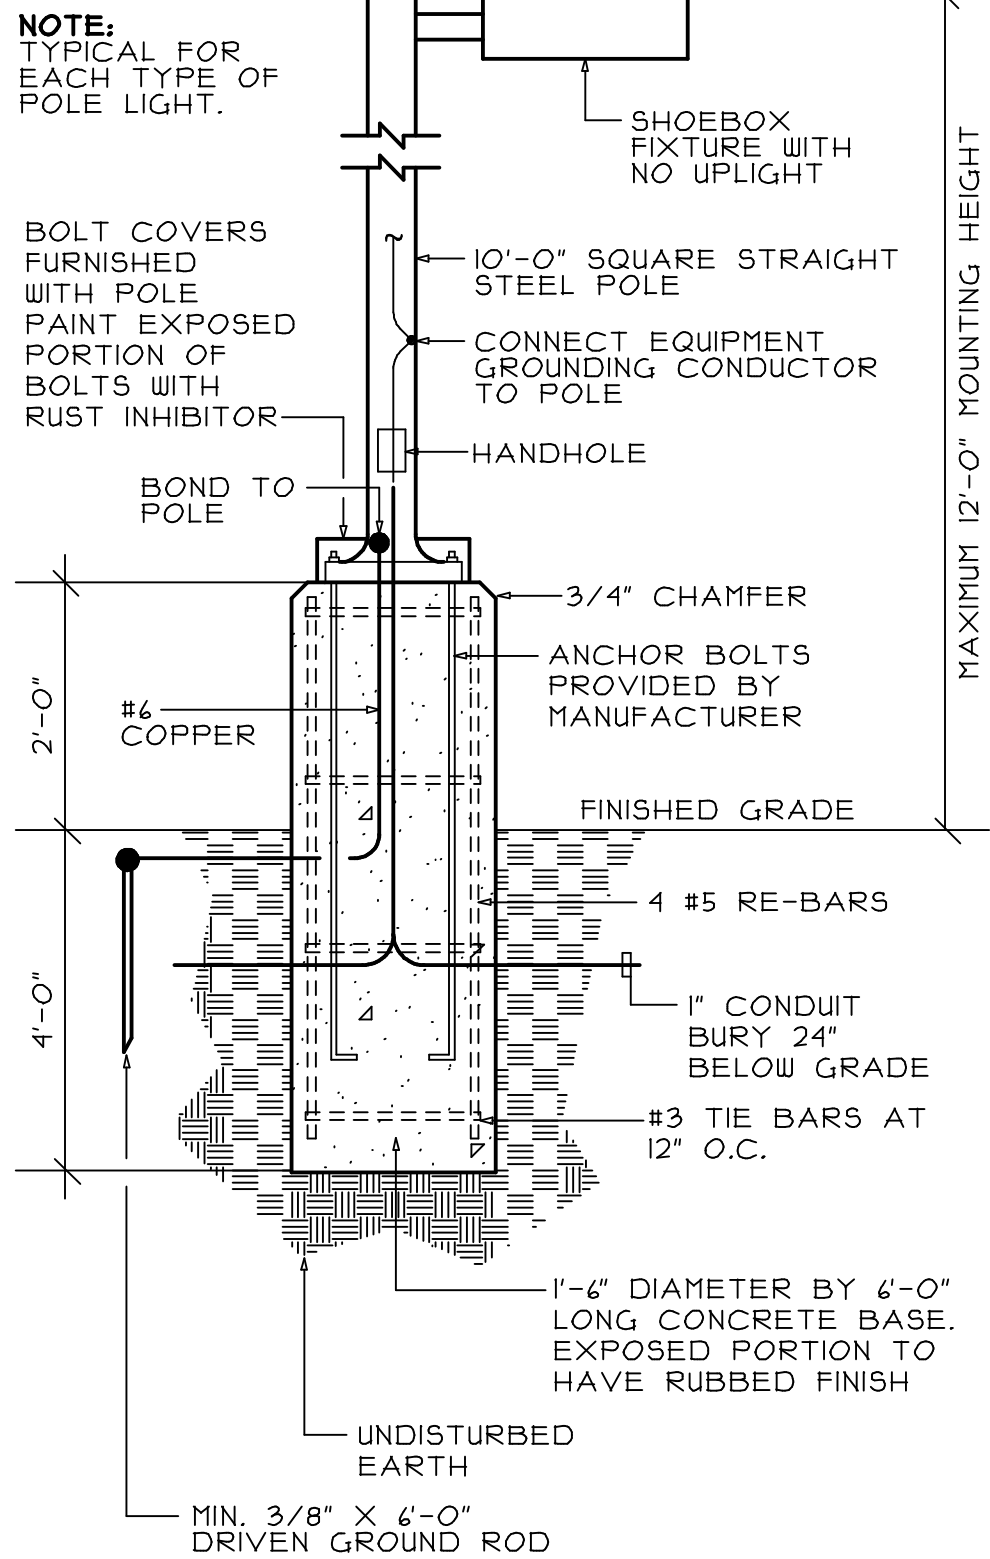

POLE BASE DETAIL
NO SCALE

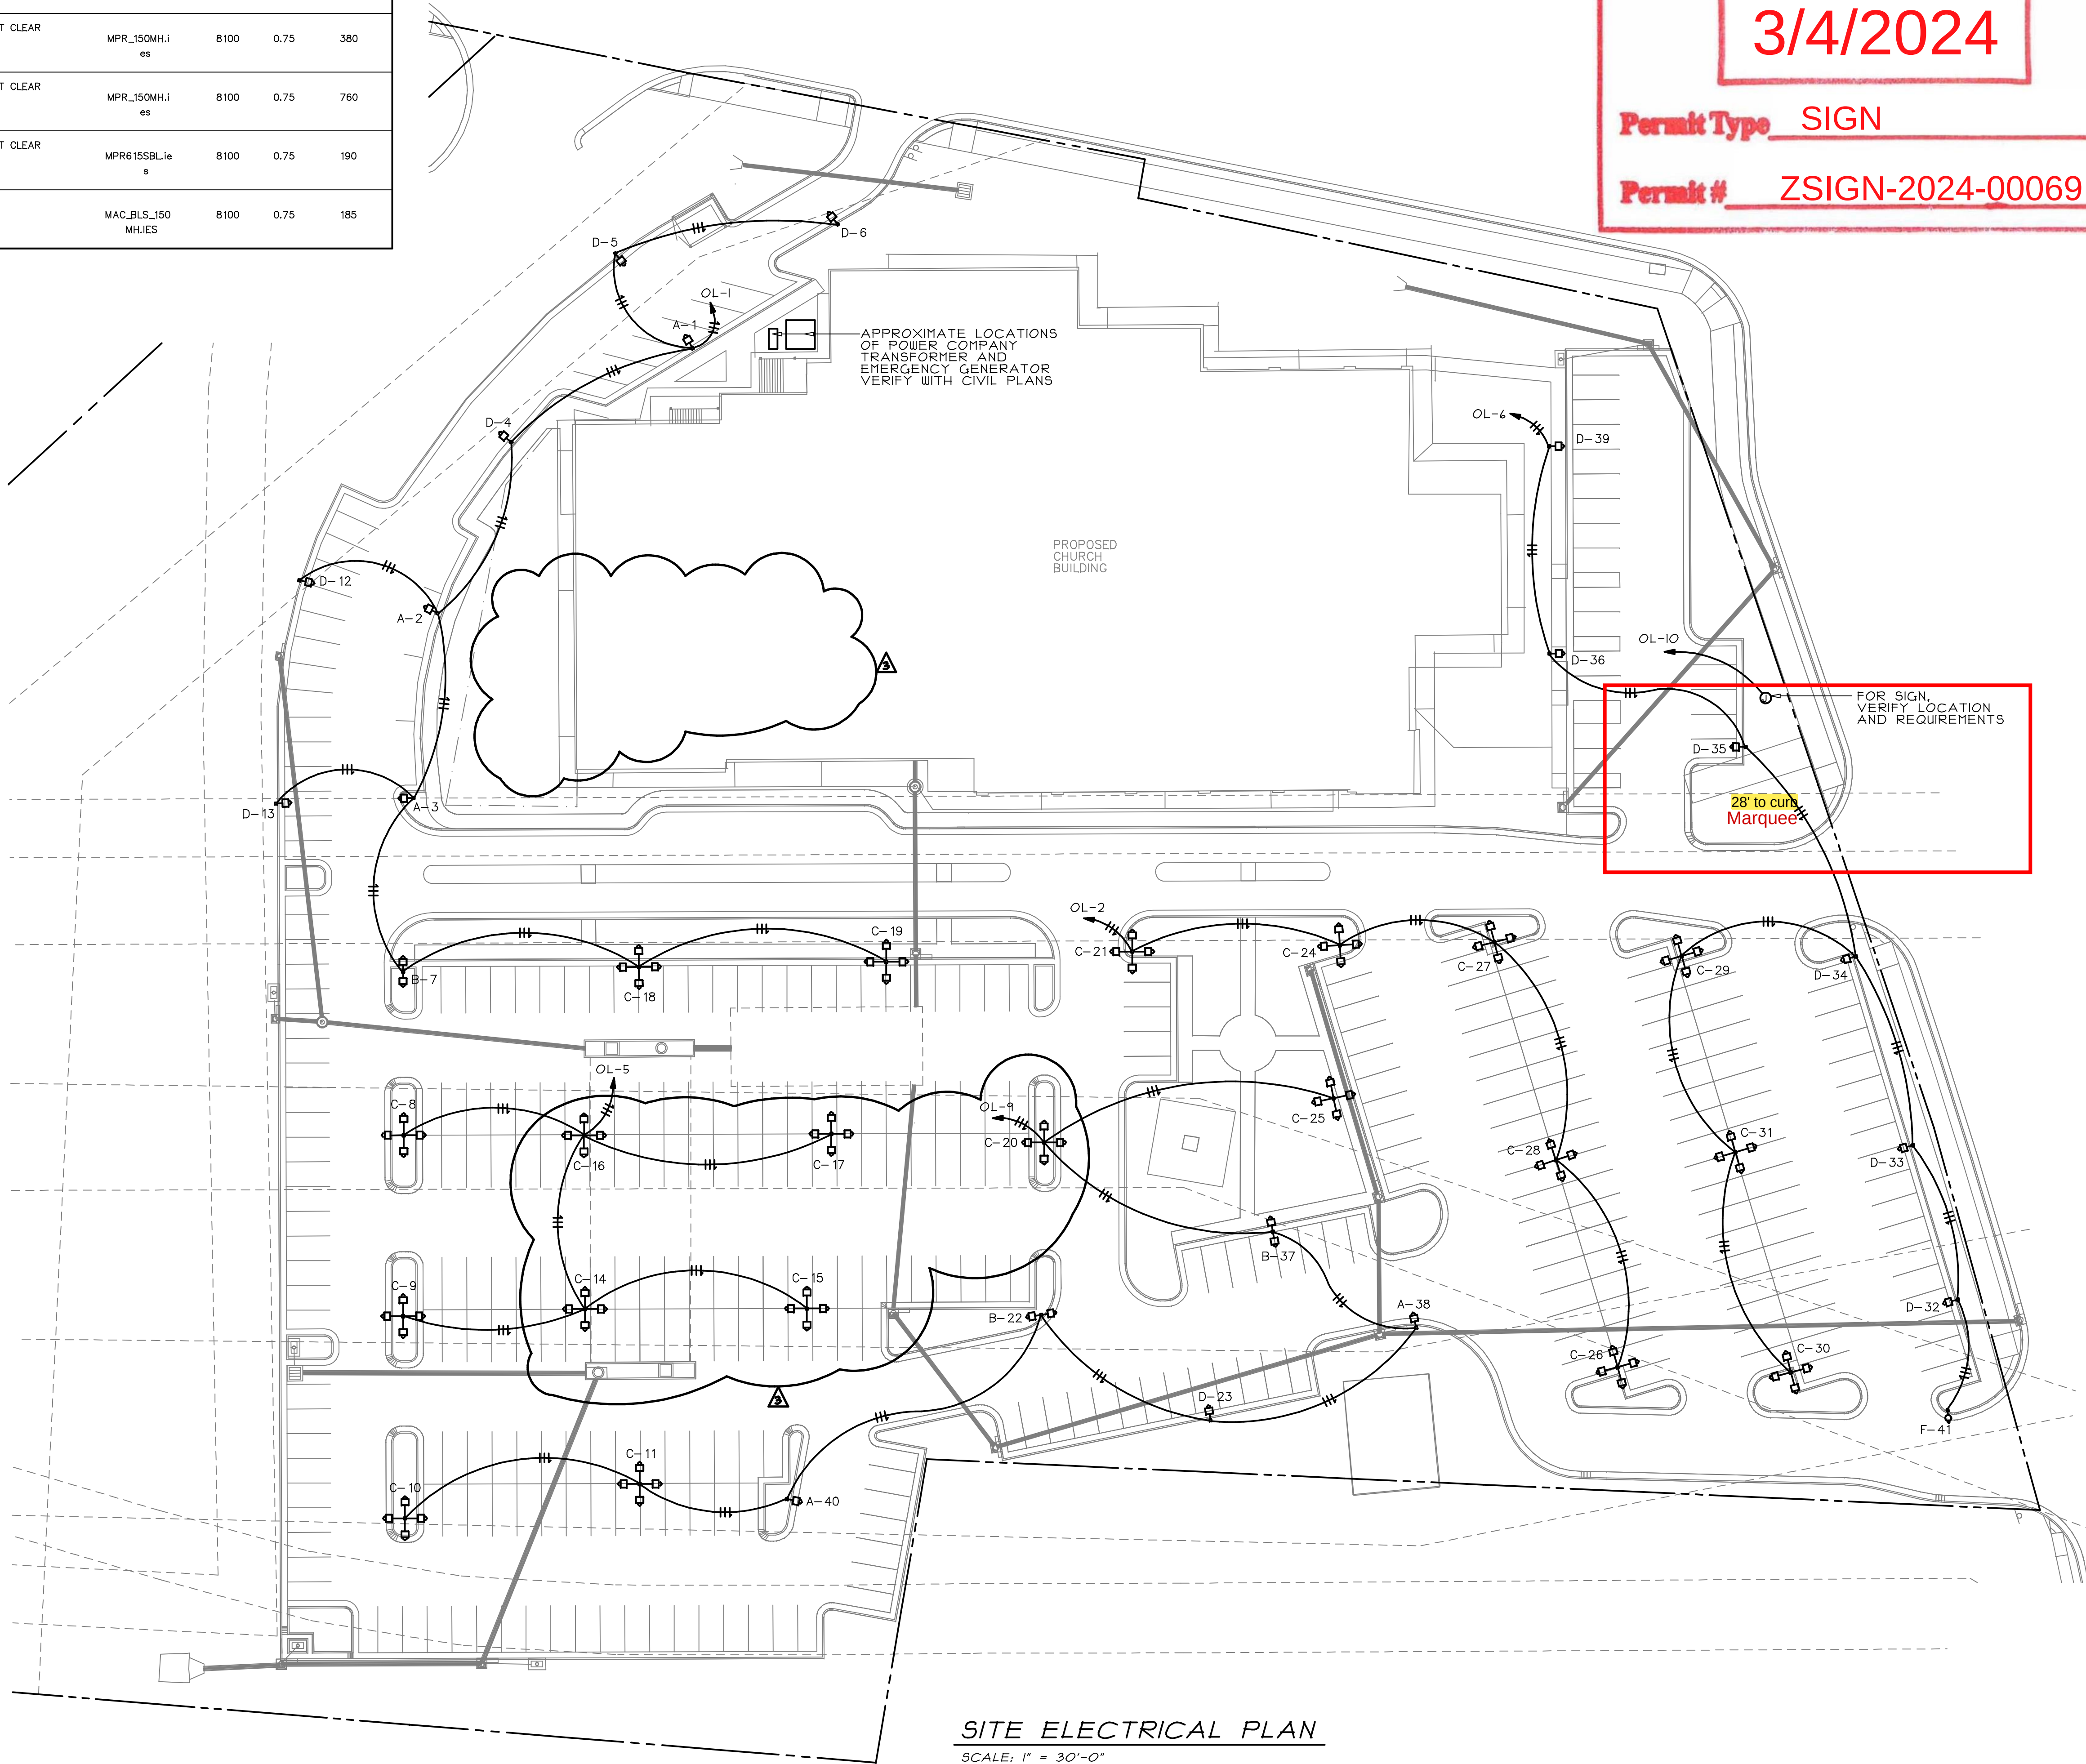

SITE ELECTRICAL PLAN
SCALE: 1" = 30'-0"

APPROVED
David B. Johnson
Zoning Administrator

3/4/2024

Permit Type SIGN


Permit # ZSIGN-2024-00069

INDUSTRIAL
COMMERCIAL

GREGORY CONSTRUCTION CO. INC.

DESIGN BUILD CONTRACTOR

9410 PRINCE WILLIAM STREET
MANASSAS, VIRGINIA 20108
(703) 368-6181 FAX (703) 368-5469

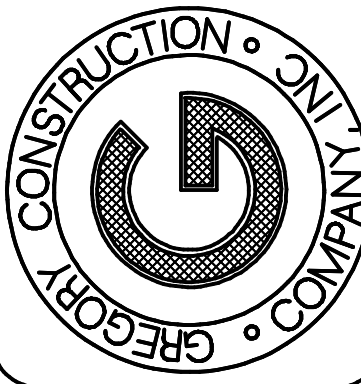

engineering, inc.

mechanical—electrical—industrial
consultants

Harrisonburg, VA. (540) 432-6272

PROJECT:

MT. OLIVE BAPTIST CHURCH - CENTREVILLE

6600 OLD CENTREVILLE ROAD

CENTREVILLE, VIRGINIA 22020

DATE: 07 JUL 08

PERMIT

REVISIONS:

08/26/08: VALUE ENGINEERING

11/01/08: COMMENT REVISIONS

04/08/10: PERMIT RESUBMITTAL

SITE
ELECTRICAL
PLAN

SHEET
E3.1

JOB No. 05133

CONFORMING SET 04/08/10